


1 FLOOR PLAN

SCALE 1/4" = 1'-0"


ELEC. MECH. NOTES

1. PROVIDE ELEC. AS REQ'D FOR MECH. EQUIP. & W/H
2. PROVIDE ELEC. AS REQ'D FOR ALL APPLIANCES
3. PROVIDE SEPARATE LIGHTING AND POWER CIRCUITS IN ALL BATHROOMS AND KITCHEN AREAS
4. ◀ TELEPHONE
5. ◀ TELEVISION/INTERNET
6. + HOSE BIB VERIFY LOCATION OF HOSE BIBS
7. VERIFY LOCATION OF FLOOR PLUGS WITH OWNERS
8. RECEPTACLES TO BE ARC FAULT PROTECTED
9. RECEPTACLES TO BE TAMPER RESISTANT
10. (SA) SMOKE ALARMS


MARK	TYPE	DESCRIPTION
A	INCANDESCENT	PENDANT LIGHT (VERIFY LIGHT TYPE WITH OWNER)
B	INCANDESCENT	RECESSED 6" ROUND
C	INCANDESCENT	WALL MOUNT VANITY LIGHT
D	INCANDESCENT	EXTERIOR LANTERNS (VERIFY SWITCHING)
E	INCANDESCENT	INTERIOR 3 SPEED 54" FAN WITH LIGHT
F	INCANDESCENT	RECESSED WITH WHITE OPAL LENS-WATERPROOF
G	INCANDESCENT	EXHAUST FAN
H	INCANDESCENT	FLOOD LIGHT
I	FLUORESCENT	1'X4' FLUORESCENT
J		
K		
L		
M		

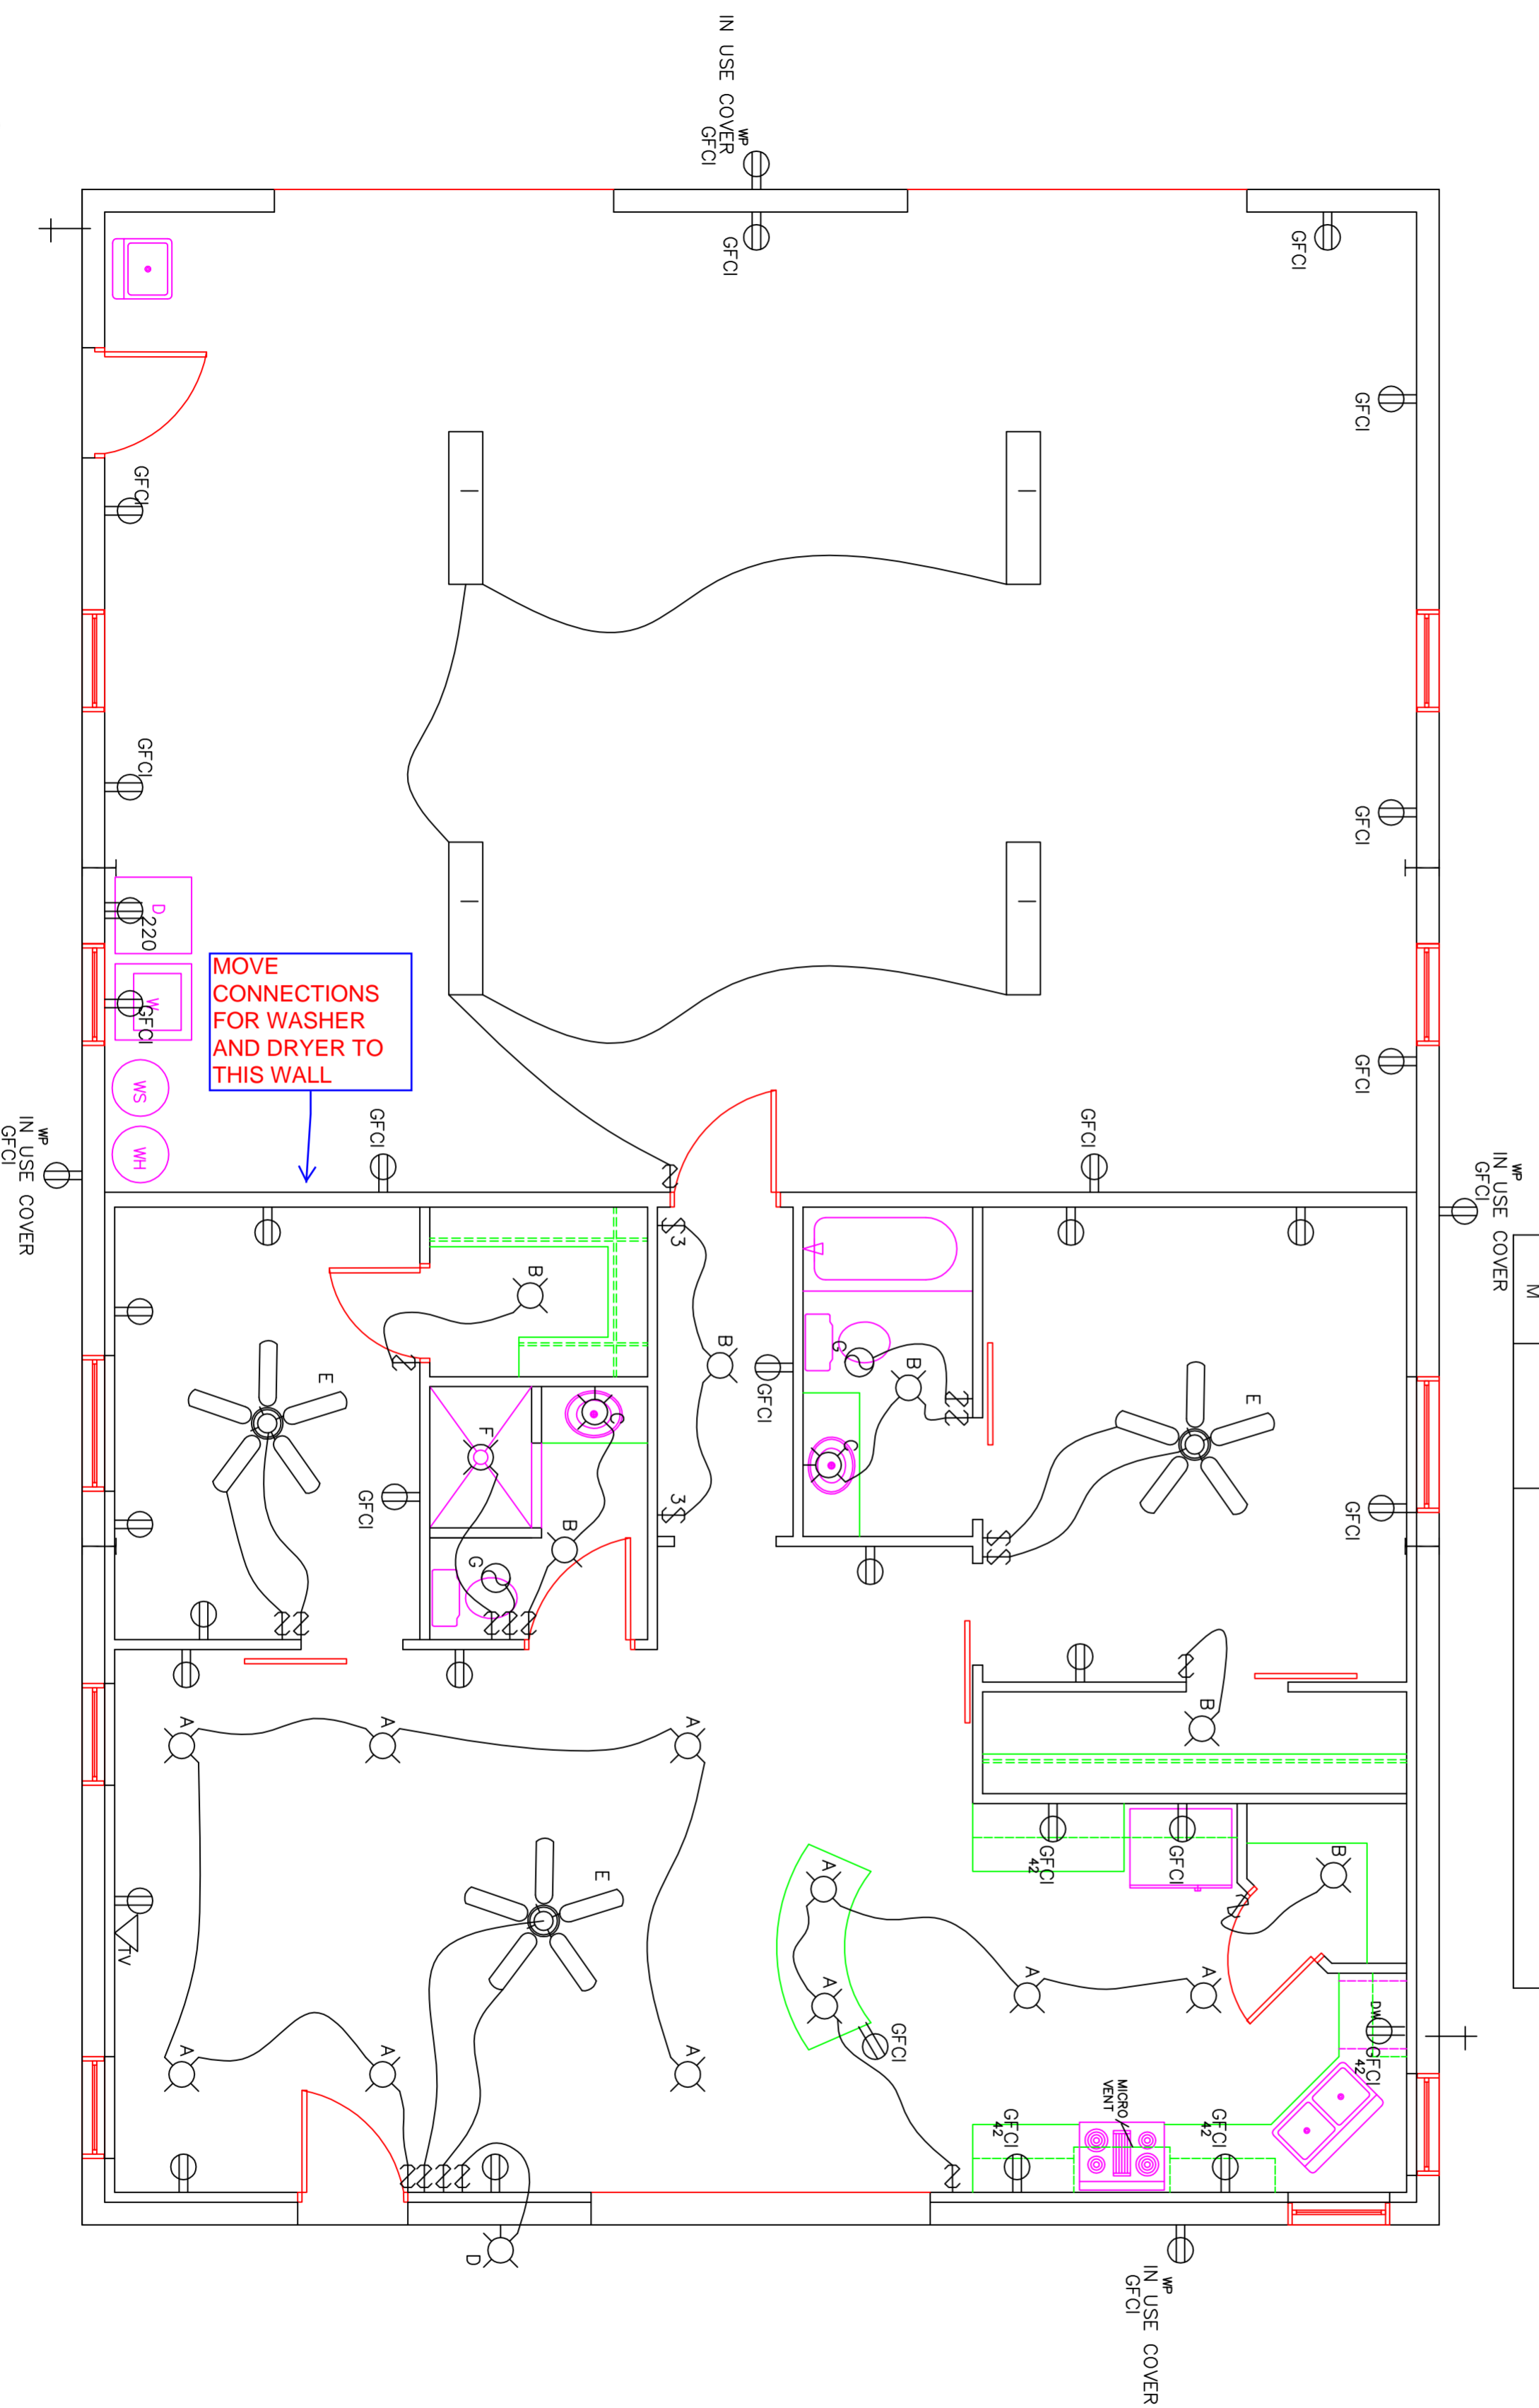


1 ELECTRIC PLAN SCALE 1/4" = 1'-0"

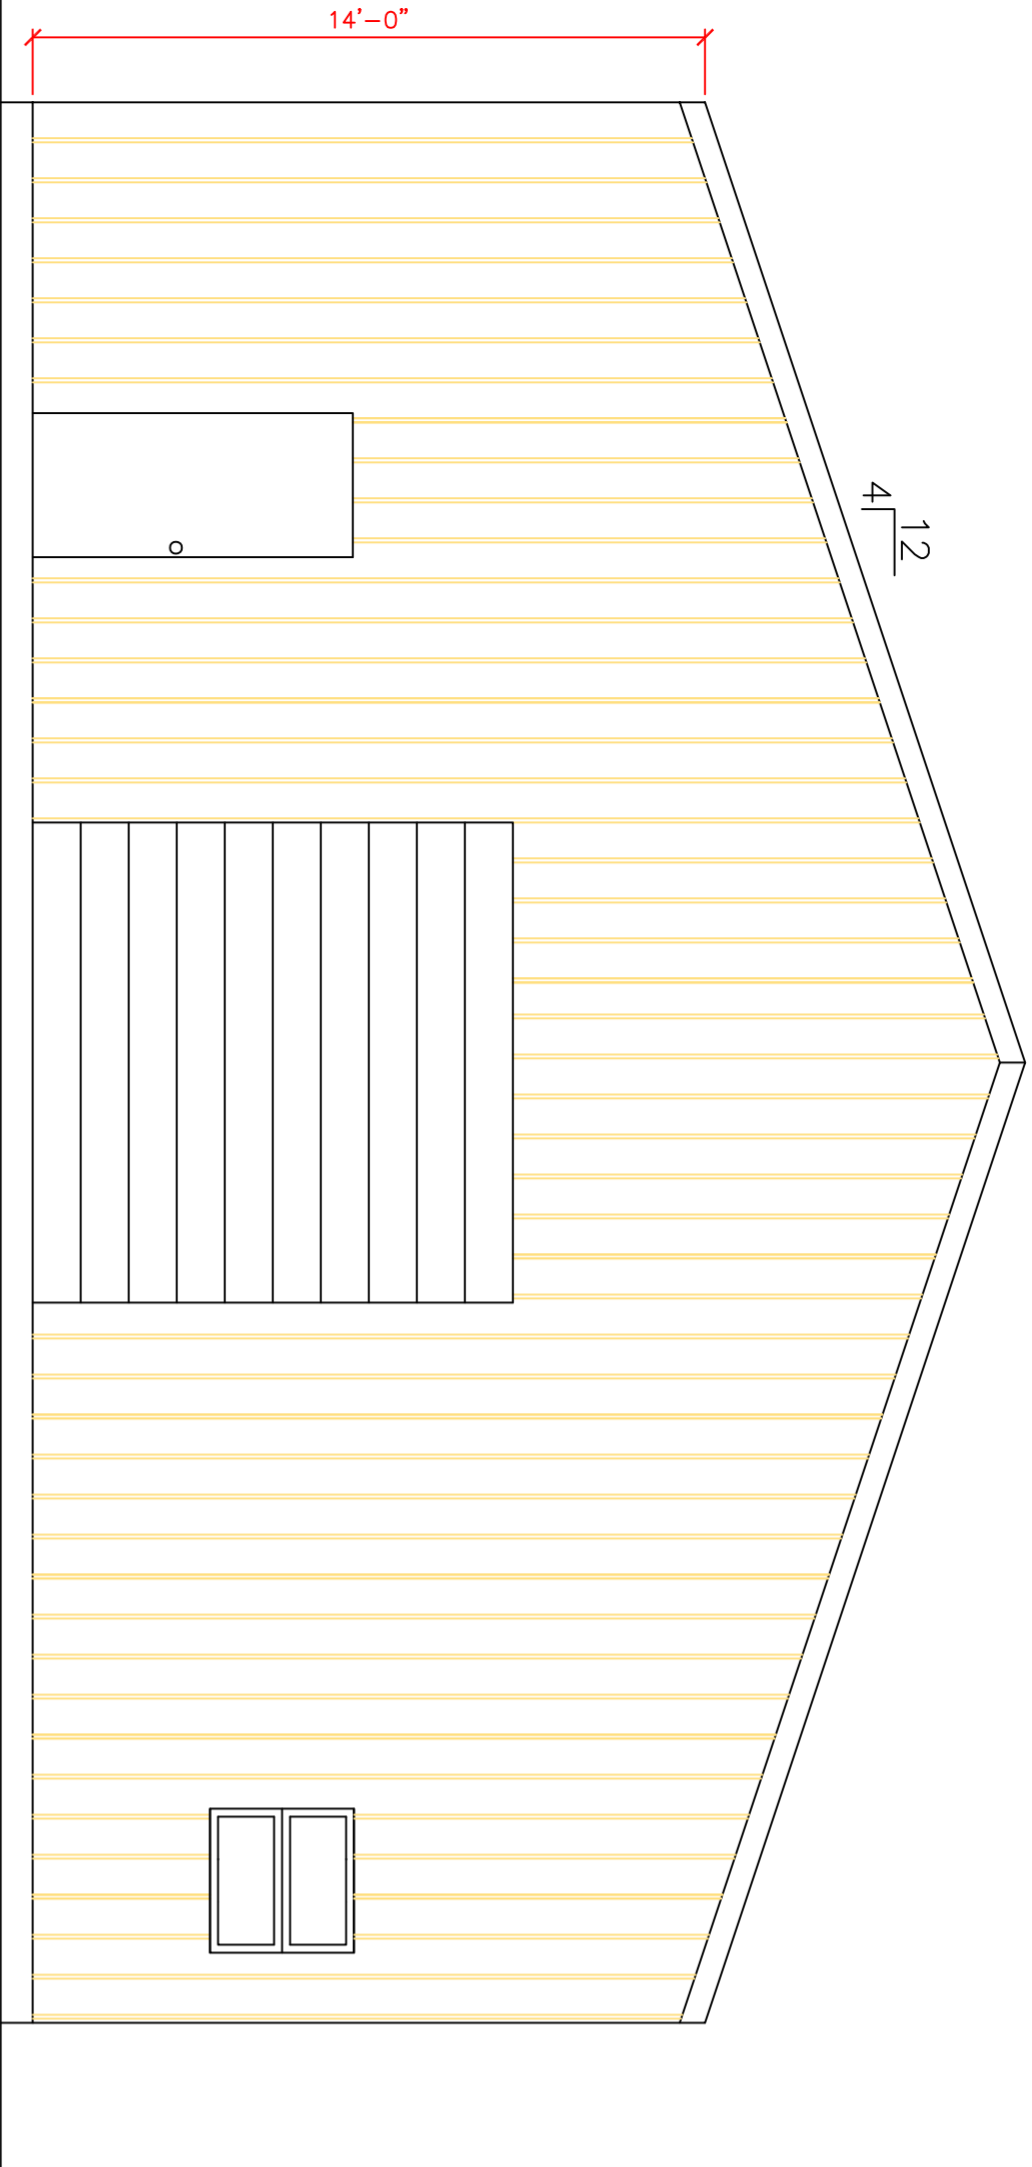

1 FRONT ELEVATION SCALE 1/4"=1'-0"

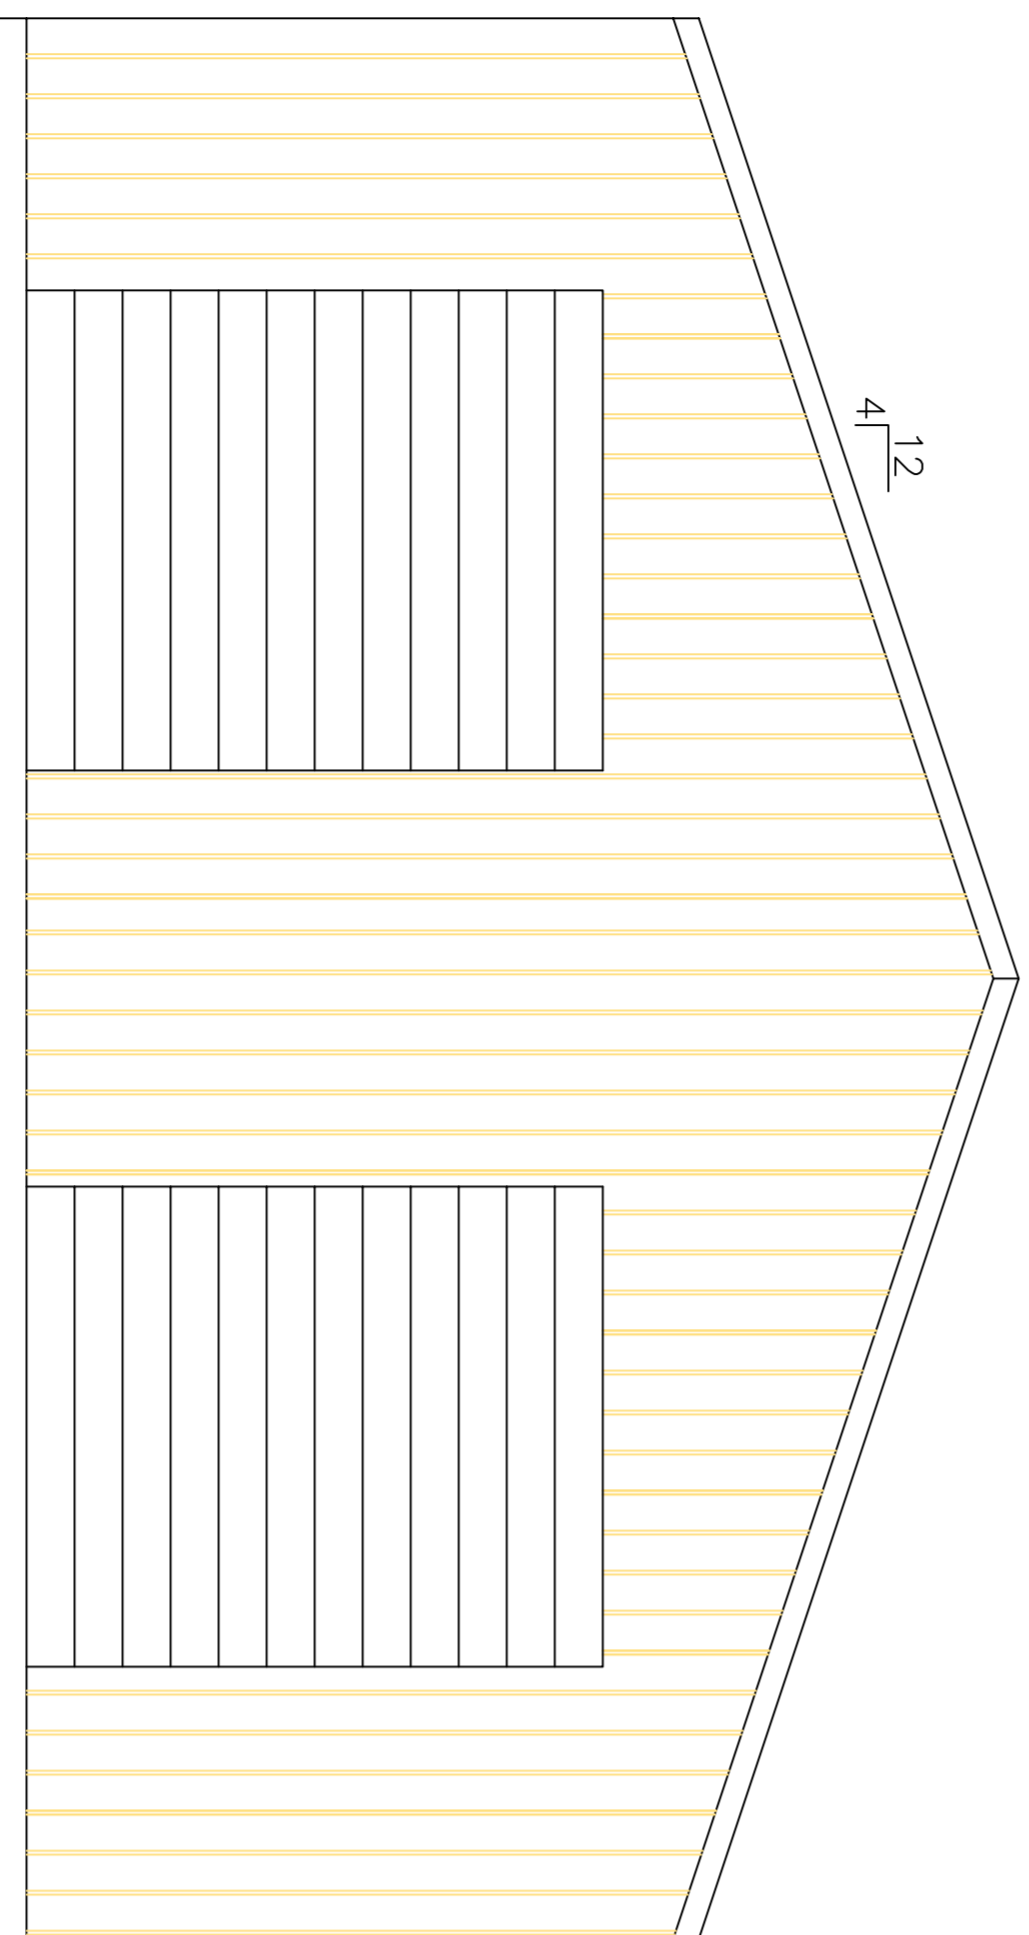

2 REAR ELEVATION SCALE 1/4"=1'-0"

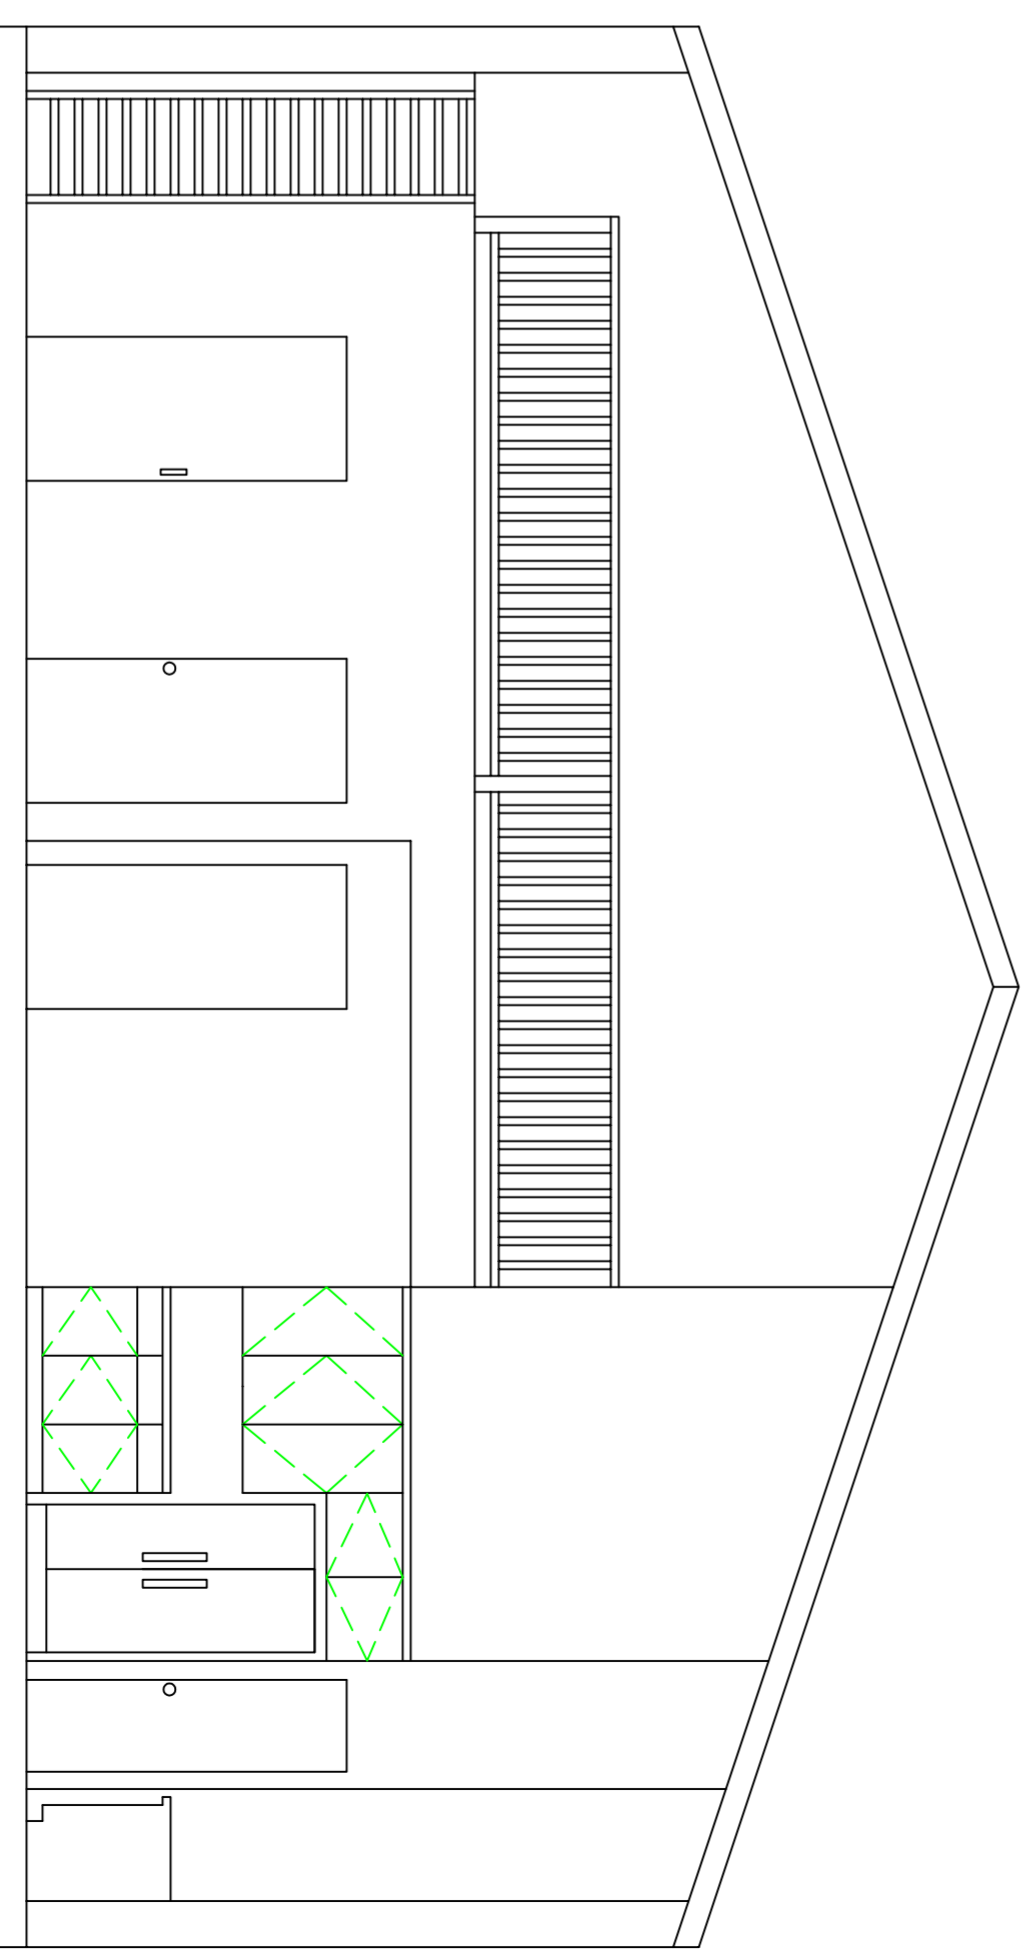

3 SECTION SCALE 1/4"=1'-0"